




1 HEATER/FAN SECTION @ DOUBLE LANE EXISTING MLOP - SIDE VIEW
NO SCALE

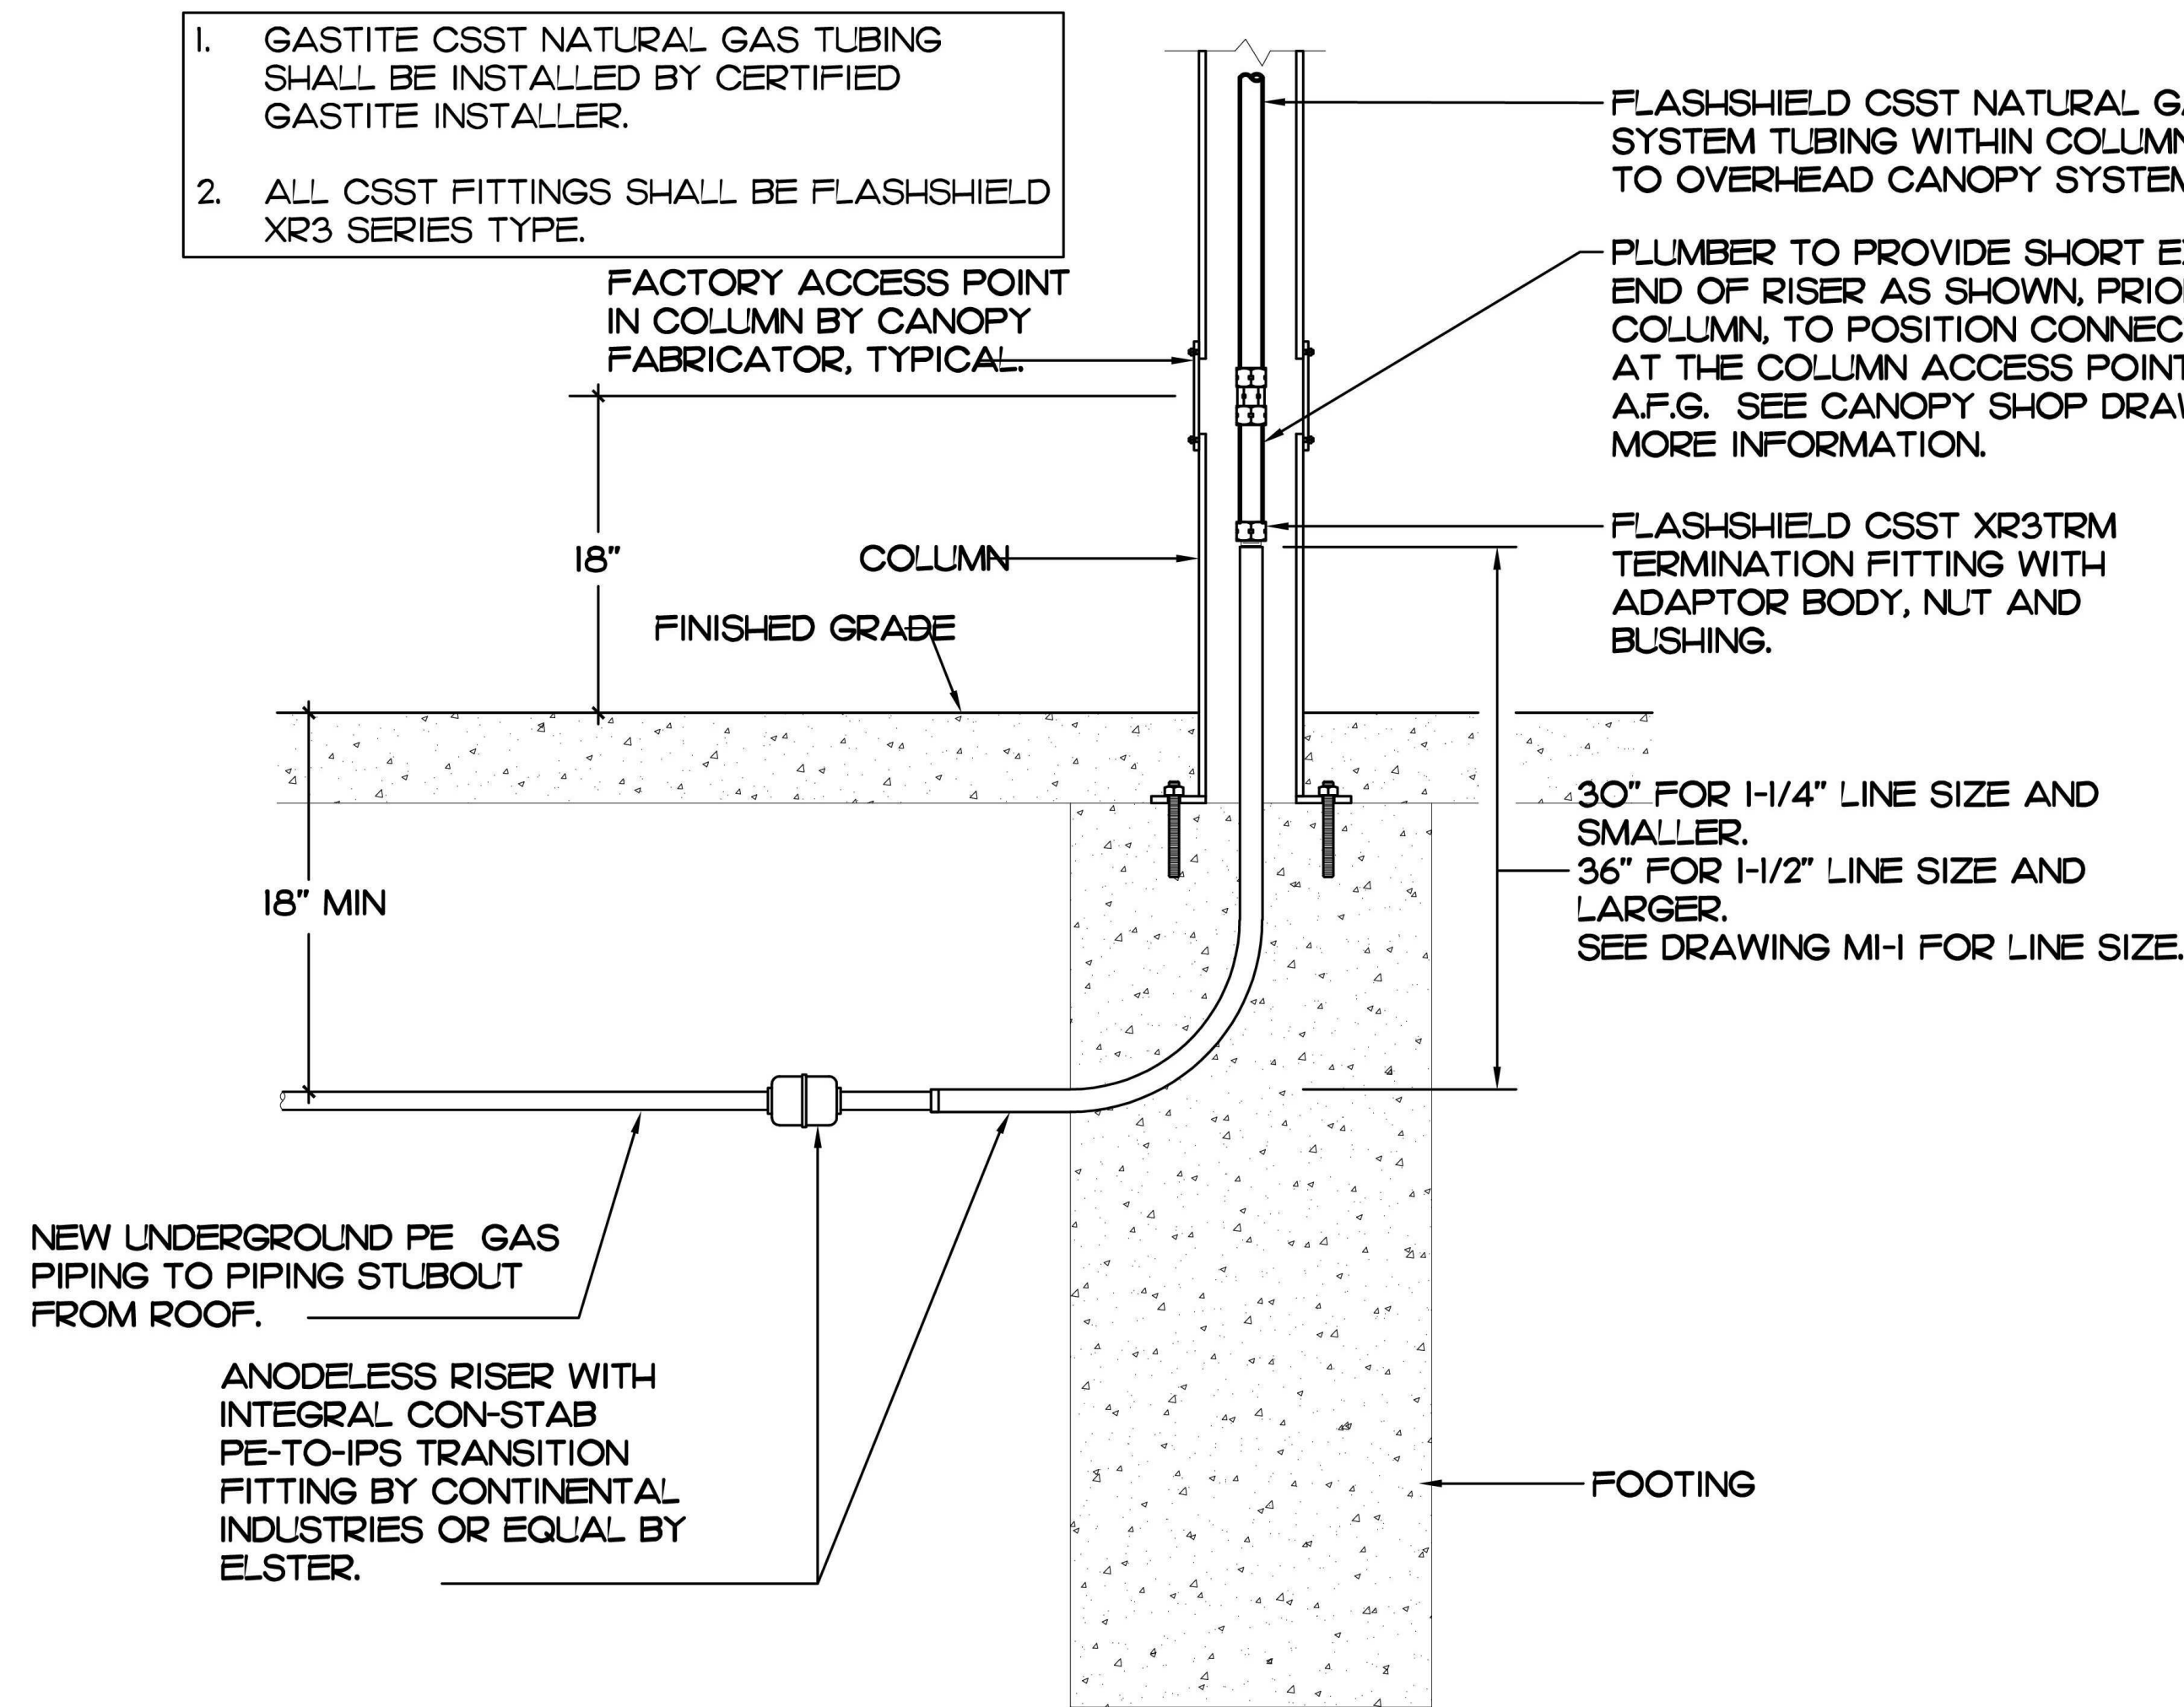


4 POLYETHYLENE AND CSST GAS TUBING CONNECTION AT COLUMN
NO SCALE

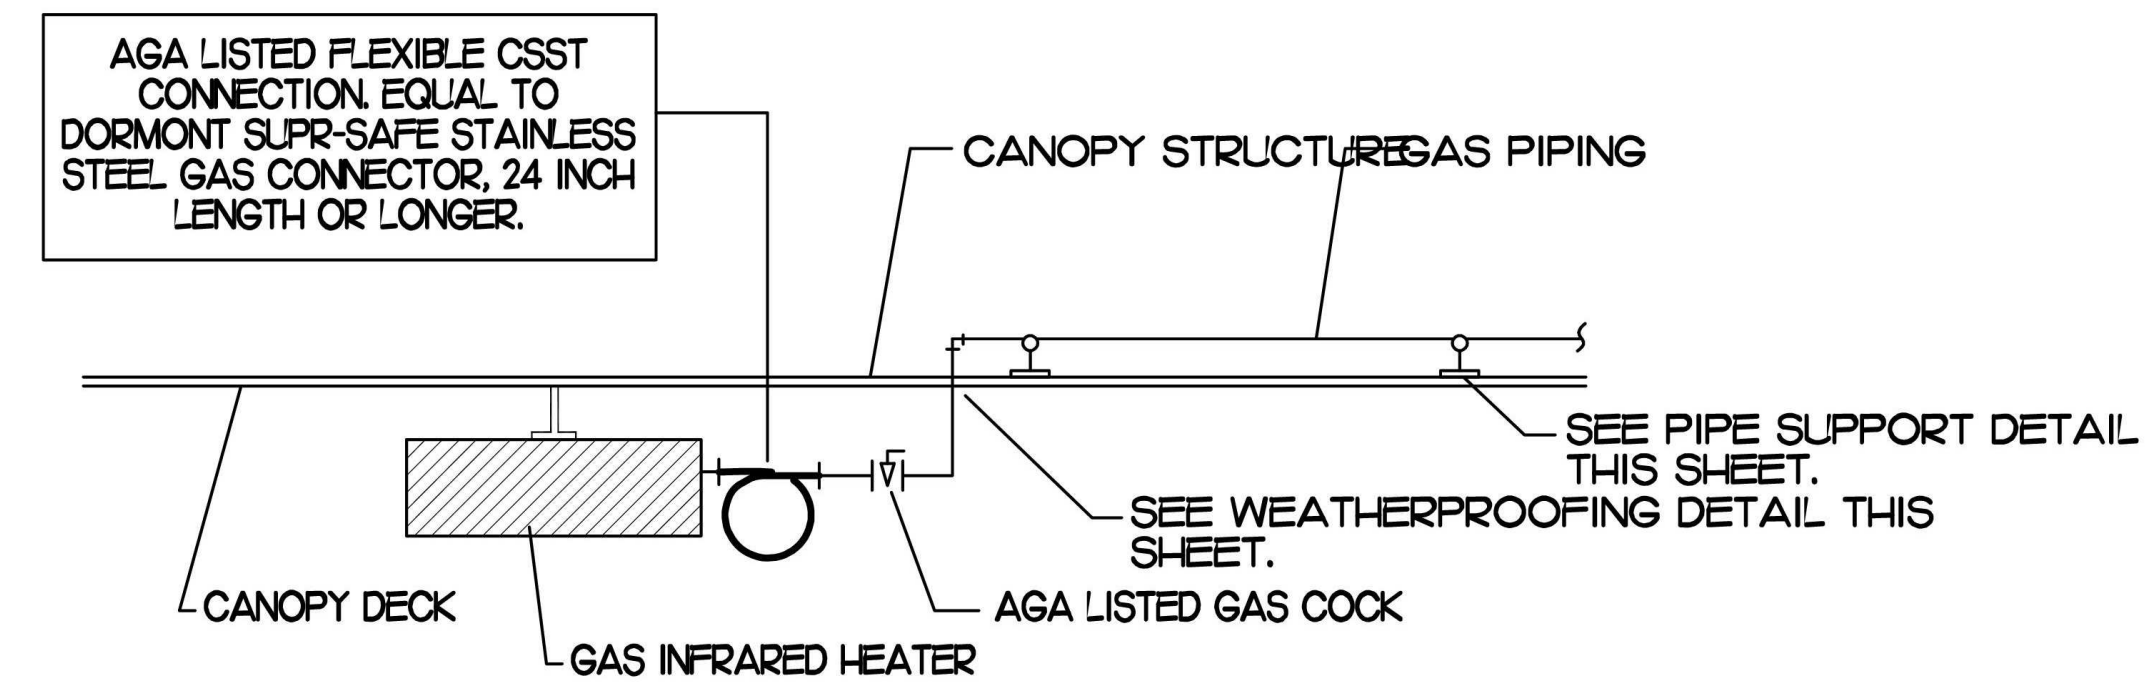

2 GAS CONNECTION AT APPLIANCE
NO SCALE

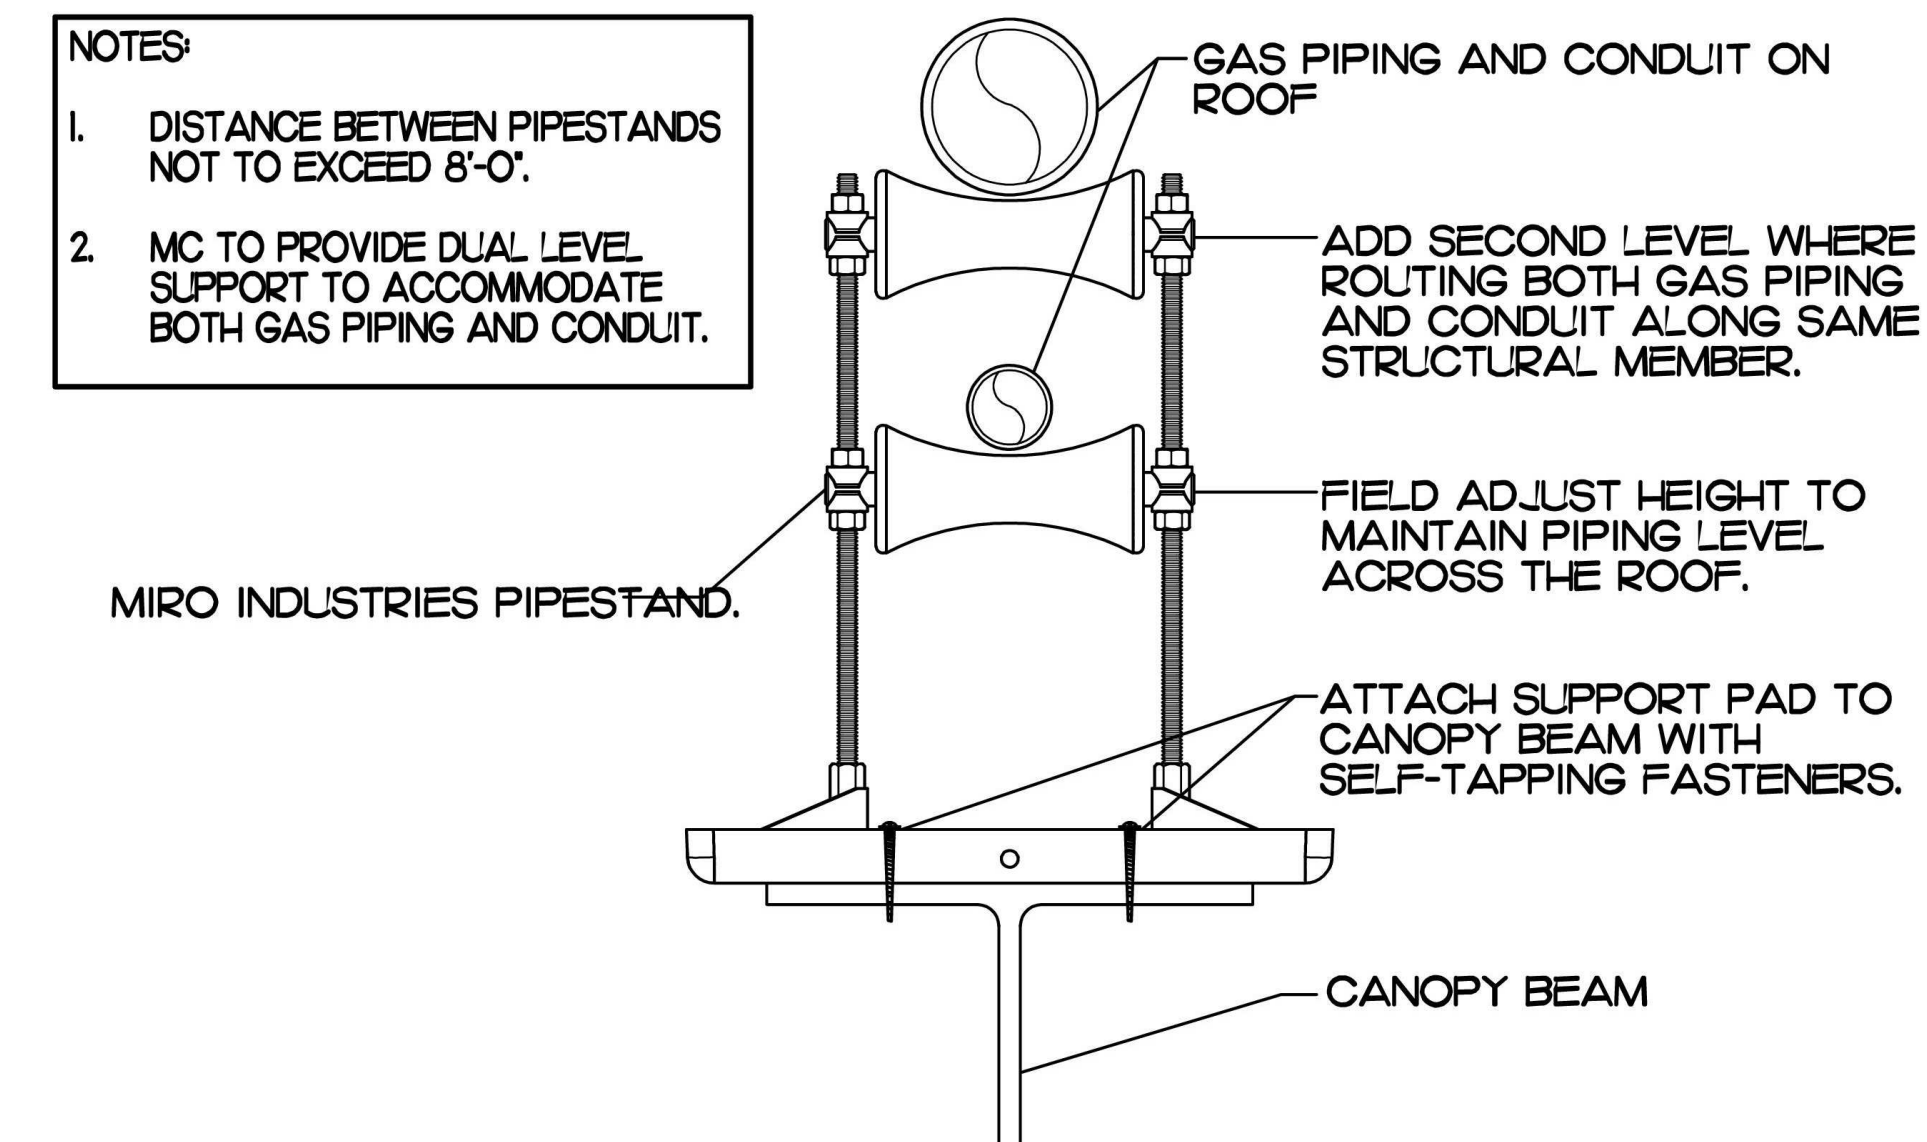

3 PIPING SUPPORT ON CANOPY
NO SCALE

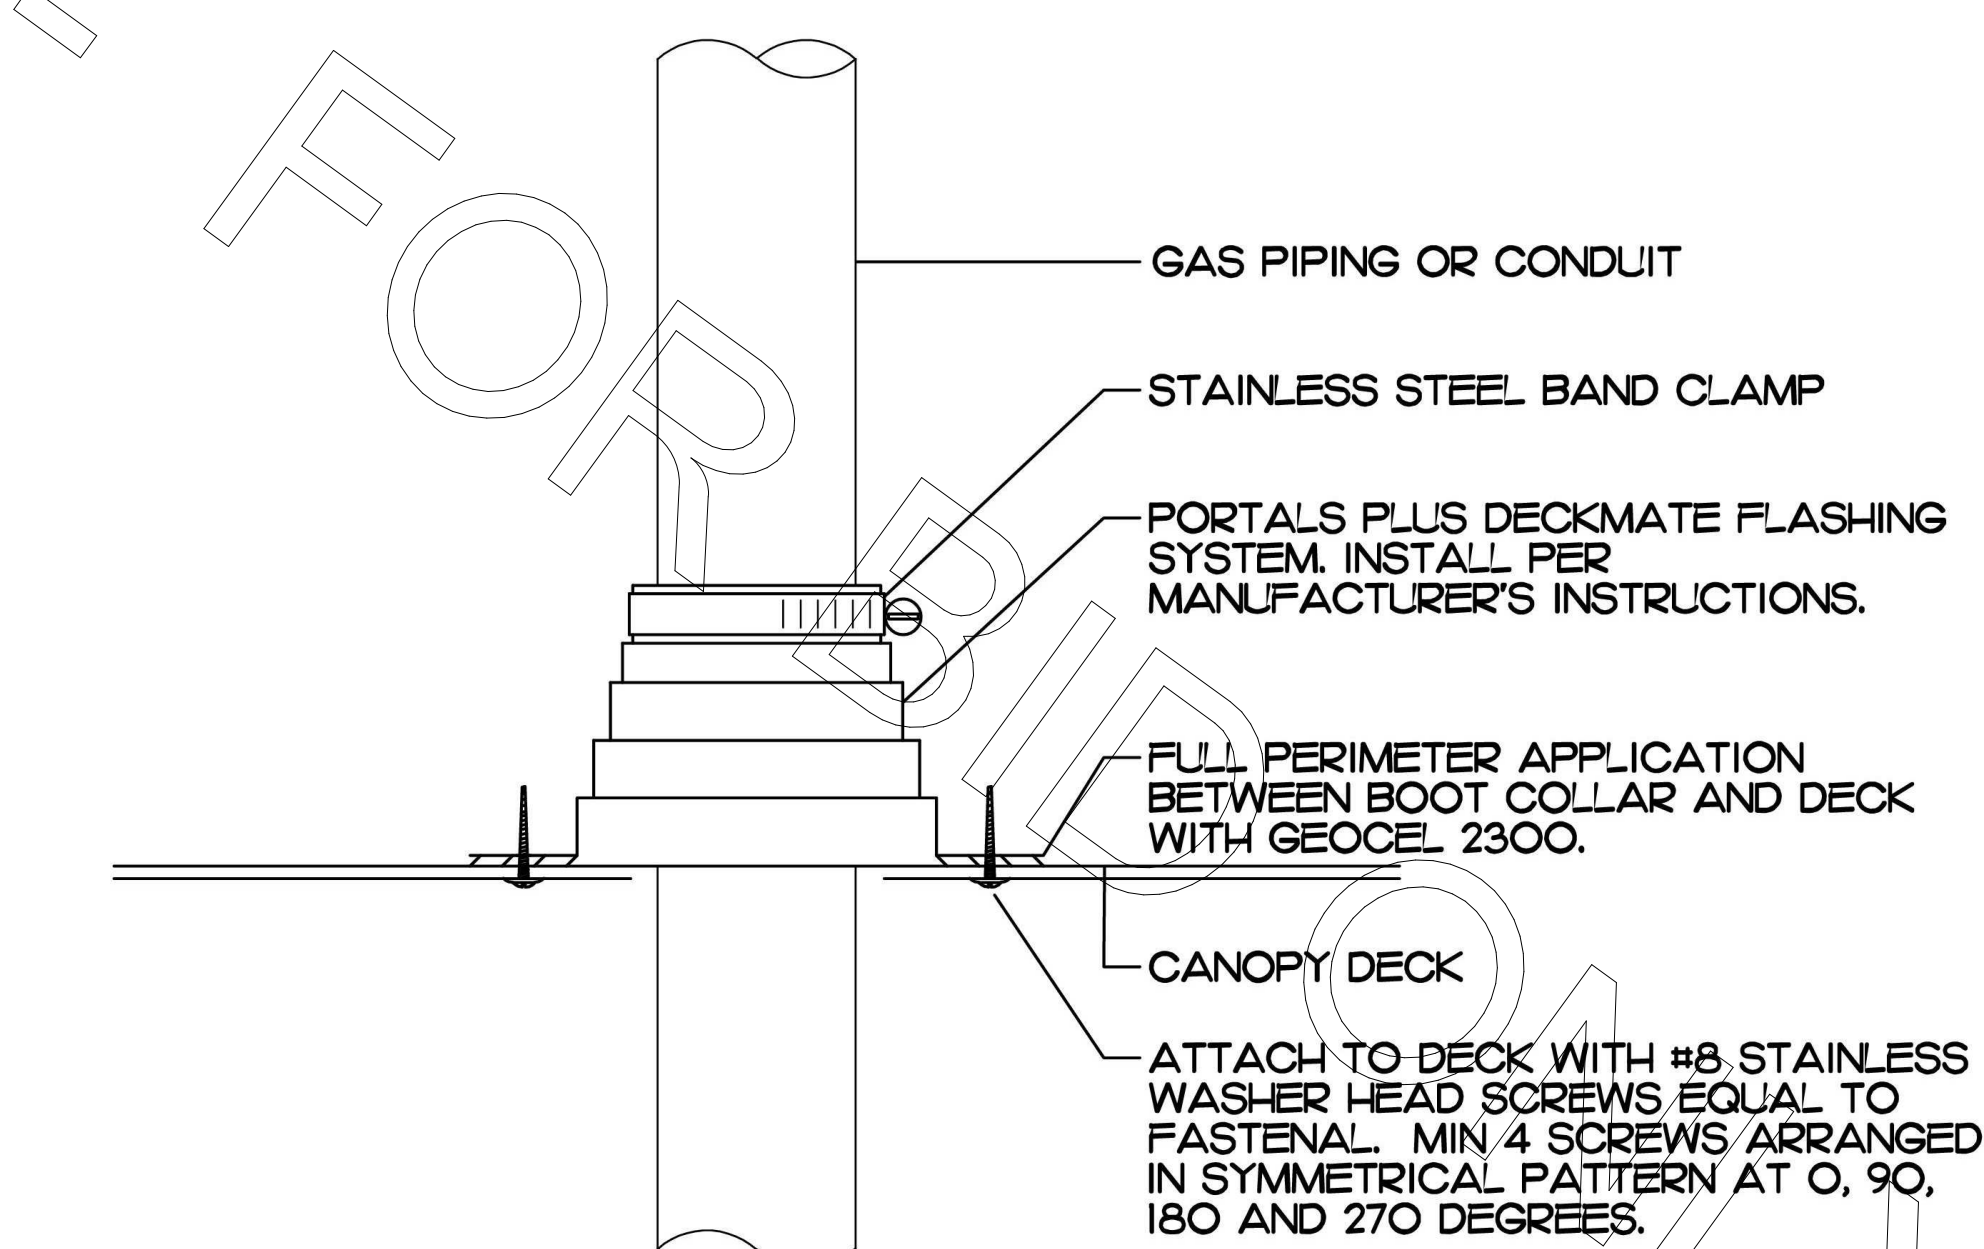

5 WEATHERPROOFING AT CANOPY PENETRATION
NO SCALE



Chick-fil-A

Chick-fil-A
5200 Buffington Road
Atlanta, Georgia 30349-2998

INTERPLAN

ARCHITECTURE
ENGINEERING
INTERIOR DESIGN
PROJECT MANAGEMENT

604 COURTLAND STREET
SUITE 100
ORLANDO, FLORIDA 32804
PH 407.645.5008
FX 407.629.9124

SEAL:
THIS DOCUMENT IS NOT FOR CONSTRUCTION
UNLESS THE ARCHITECT OR ENGINEER'S
SIGNATURE AND SEAL APPEAR BELOW

CHICK-FIL-A
Cherokee Place
115 Cherokee Place, Cartersville, GA 30121

FSR# 00534

REVISION SCHEDULE
NO. DATE DESCRIPTION

CONSULTANT PROJECT # 2017.0149
PRINTED FOR BID
DATE 11.20.17
DRAWN BY Designer

Information contained on this drawing and in all digital files produced for above named project may not be reproduced in any manner without express written or verbal consent from Interplan LLC. REPRODUCTION OF THESE DOCUMENTS TO THE ORIGINAL SIZE OR LARGER FOR ANY PURPOSE IS PROHIBITED. REPRODUCTIONS, CHANGES OR ASSIGNMENTS ARE PROHIBITED.

SHEET PLUMBING DETAILS

SHEET NUMBER
P-280